



PROJECT TITLE

STREET ADDRESS
CITY, STATE ZIP



FSB INDUSTRIES

*"Making the most
of our Enterprise"*

DRAWN BY:


DATE:

REVISED BY:

DATE:

APPROVED BY:

DATE:

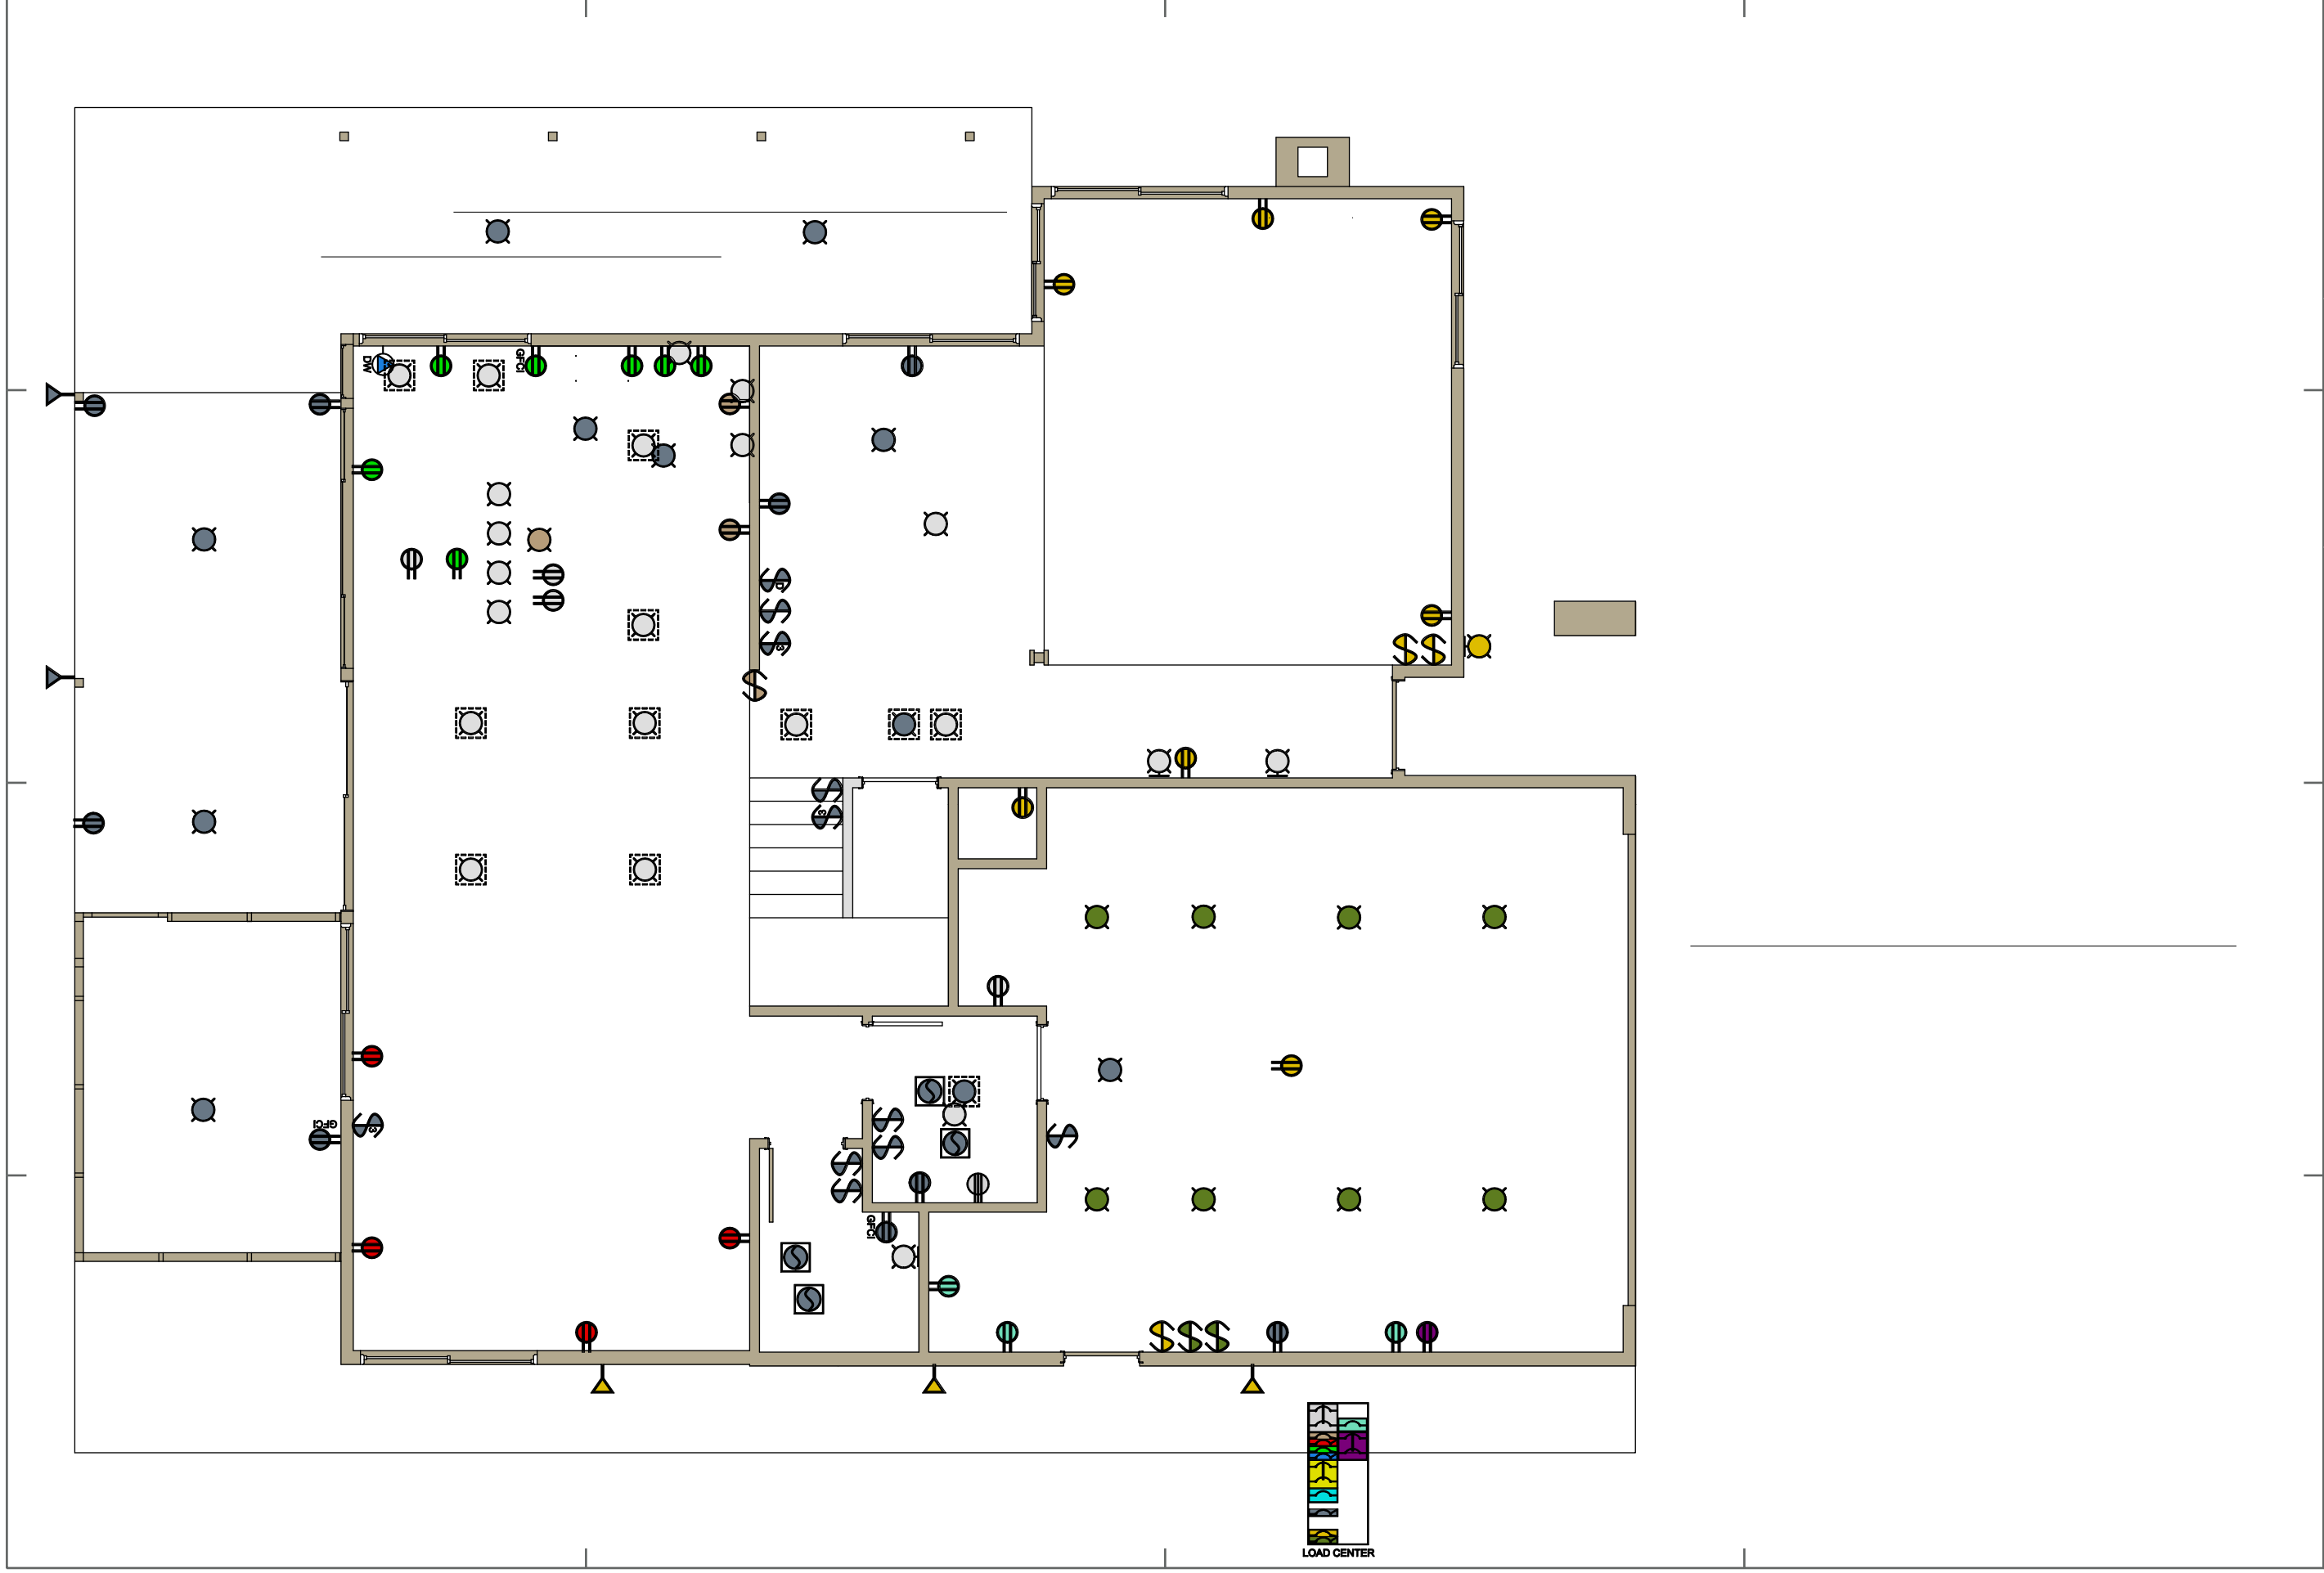

BORIK REMODEL
 1374 BLUE FALLS DRIVE
 CHULA VISTA, CA 91910

**1ST FLOOR
 ELECTRICAL PLAN**

#	REVISION	DATE
0		
1		
2		
3		
4		

E-NNN
 N OF N